

Napa County Office of Education  
Administration Bldg. & Camille Creek  
Battery Energy Storage System

## Addendum 1:

Camille Creek Existing Conduit Map

&

POI Location Clarification

## Camille Creek Existing Conduit Map



Equipment Pad to A: = no existing conduit, must be excavated and installed

A to B: existing conduits = (3) 4", (2) 2" & (1) 1"

B to C: existing conduits = (3) 4", (2) 2" & (1) 1"

C to D: no existing conduits. A section of sidewalk will have to be removed, conduits installed, and the sidewalk re-poured "See Below"


D to E: existing conduits = (3) 4"

E to AC Disconnect: no existing conduits. Asphalt must be excavated, conduits installed, and asphalt patched




# BESS SYSTEM FOR CAMILLE CREEK COMMUNITY SCHOOL

2097 IMOLA AVE, NAPA CA 94558

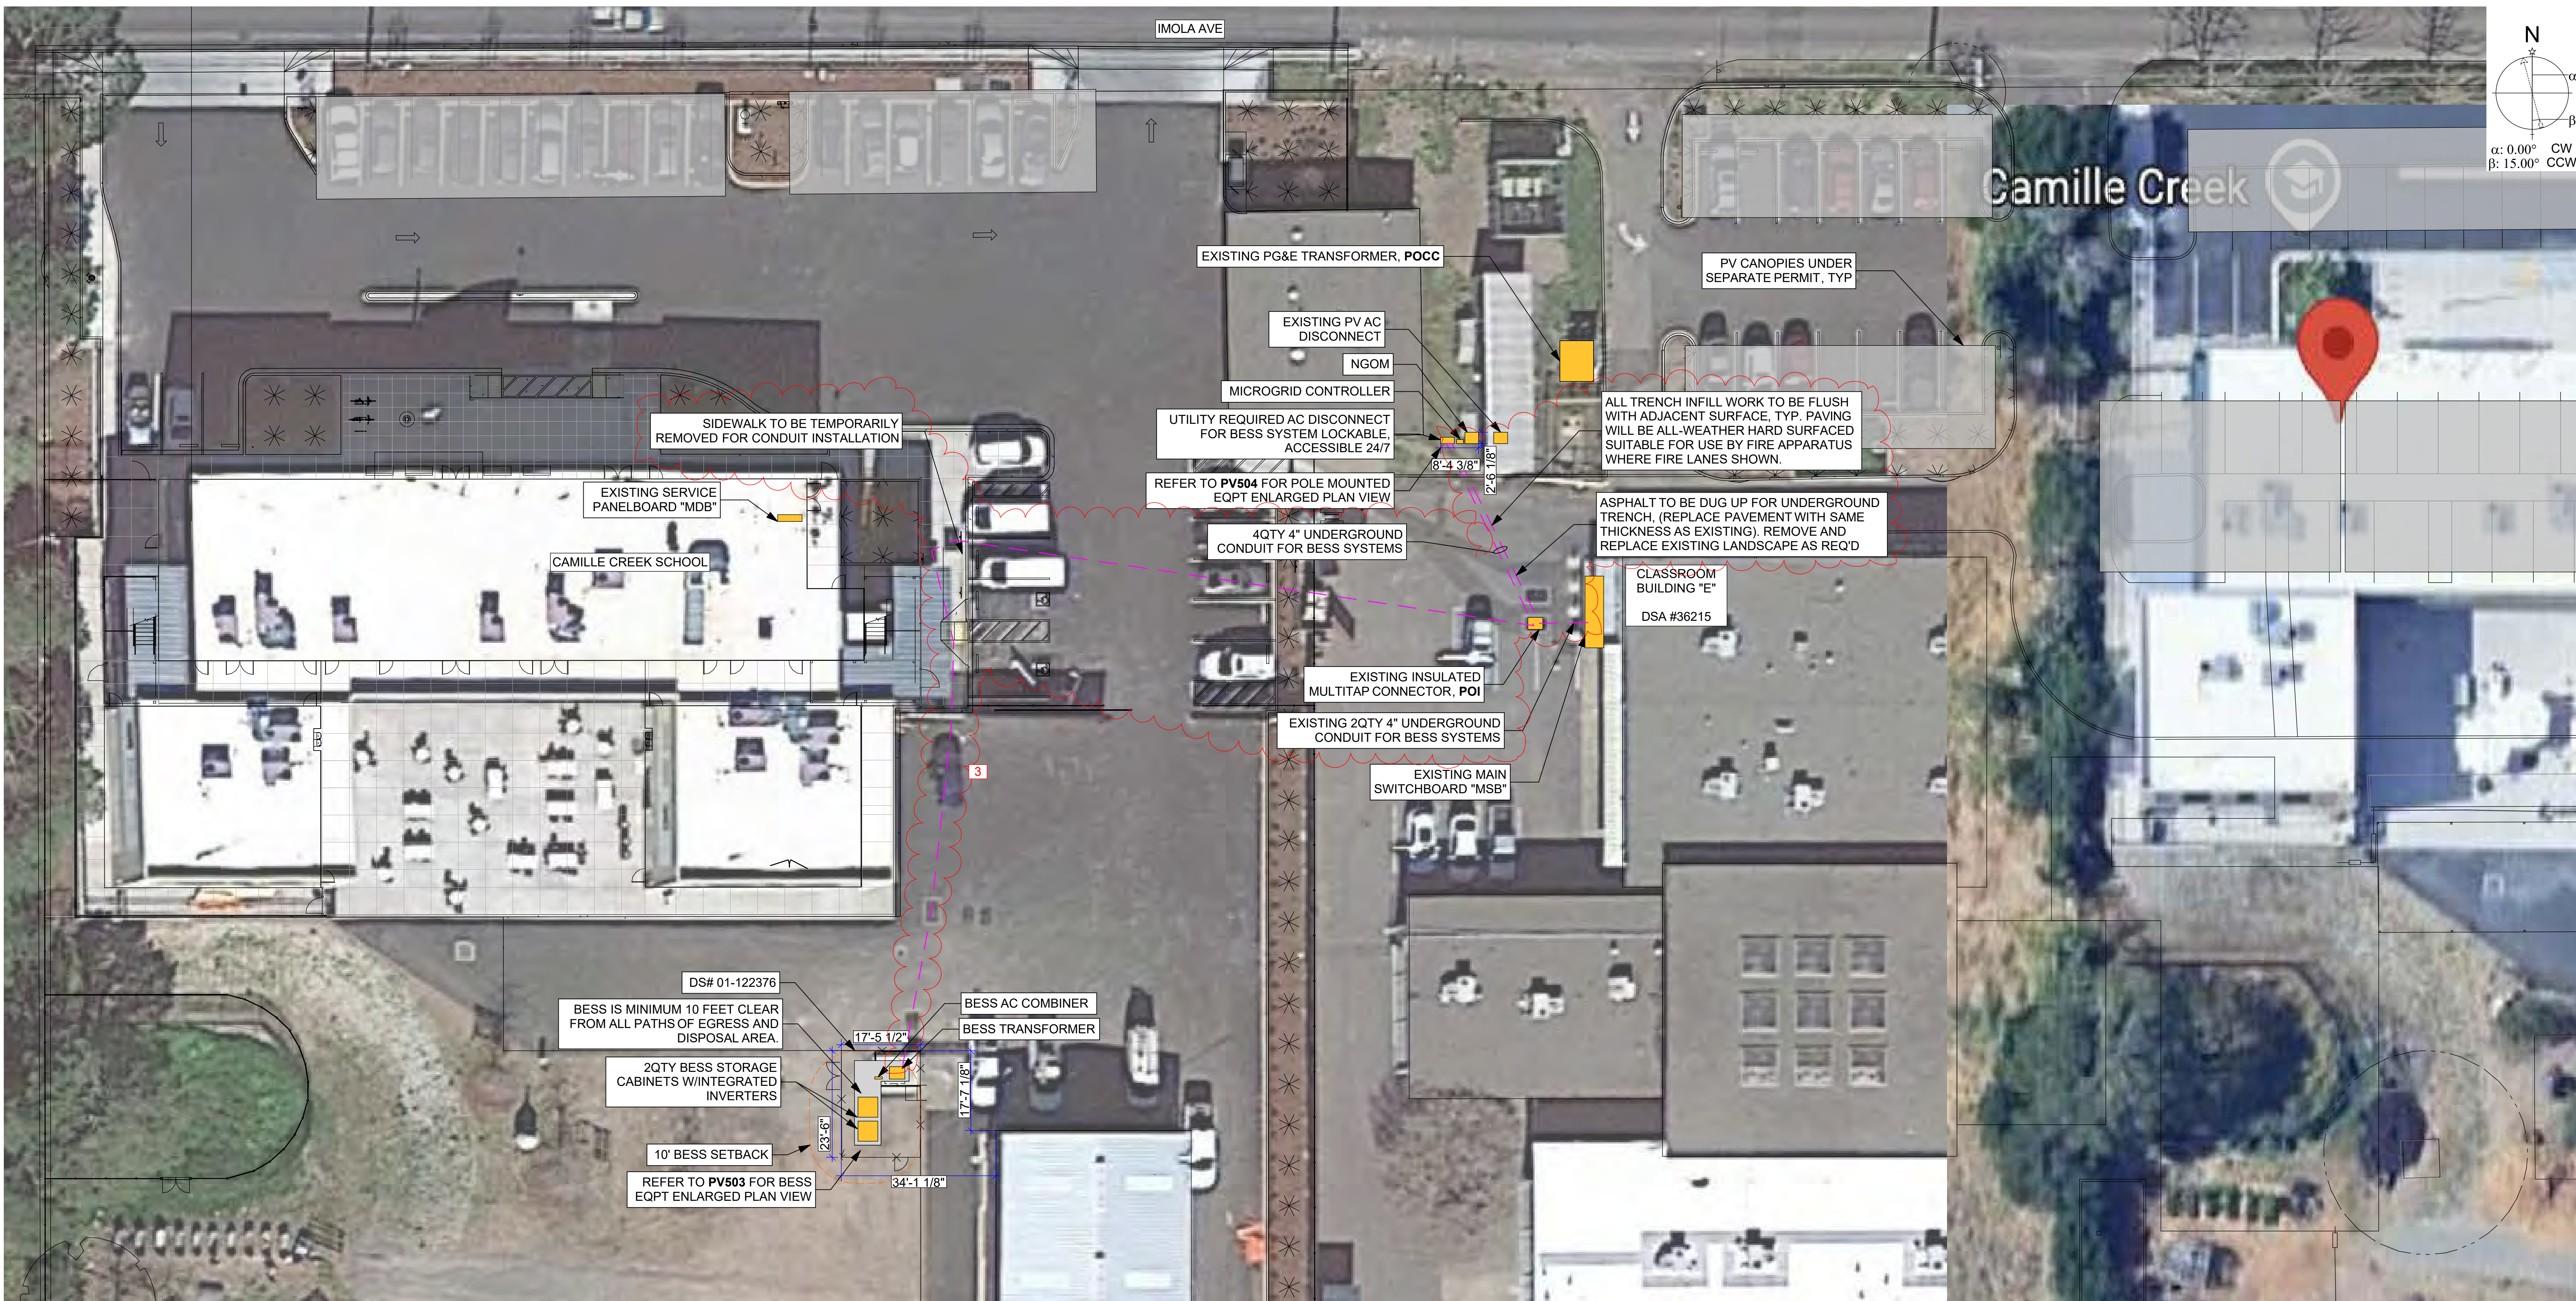

1 BESS SYSTEM WITH 250.00 kWac (500.00 kWh) OF BATTERY STORAGE

0 8' 16' 32'

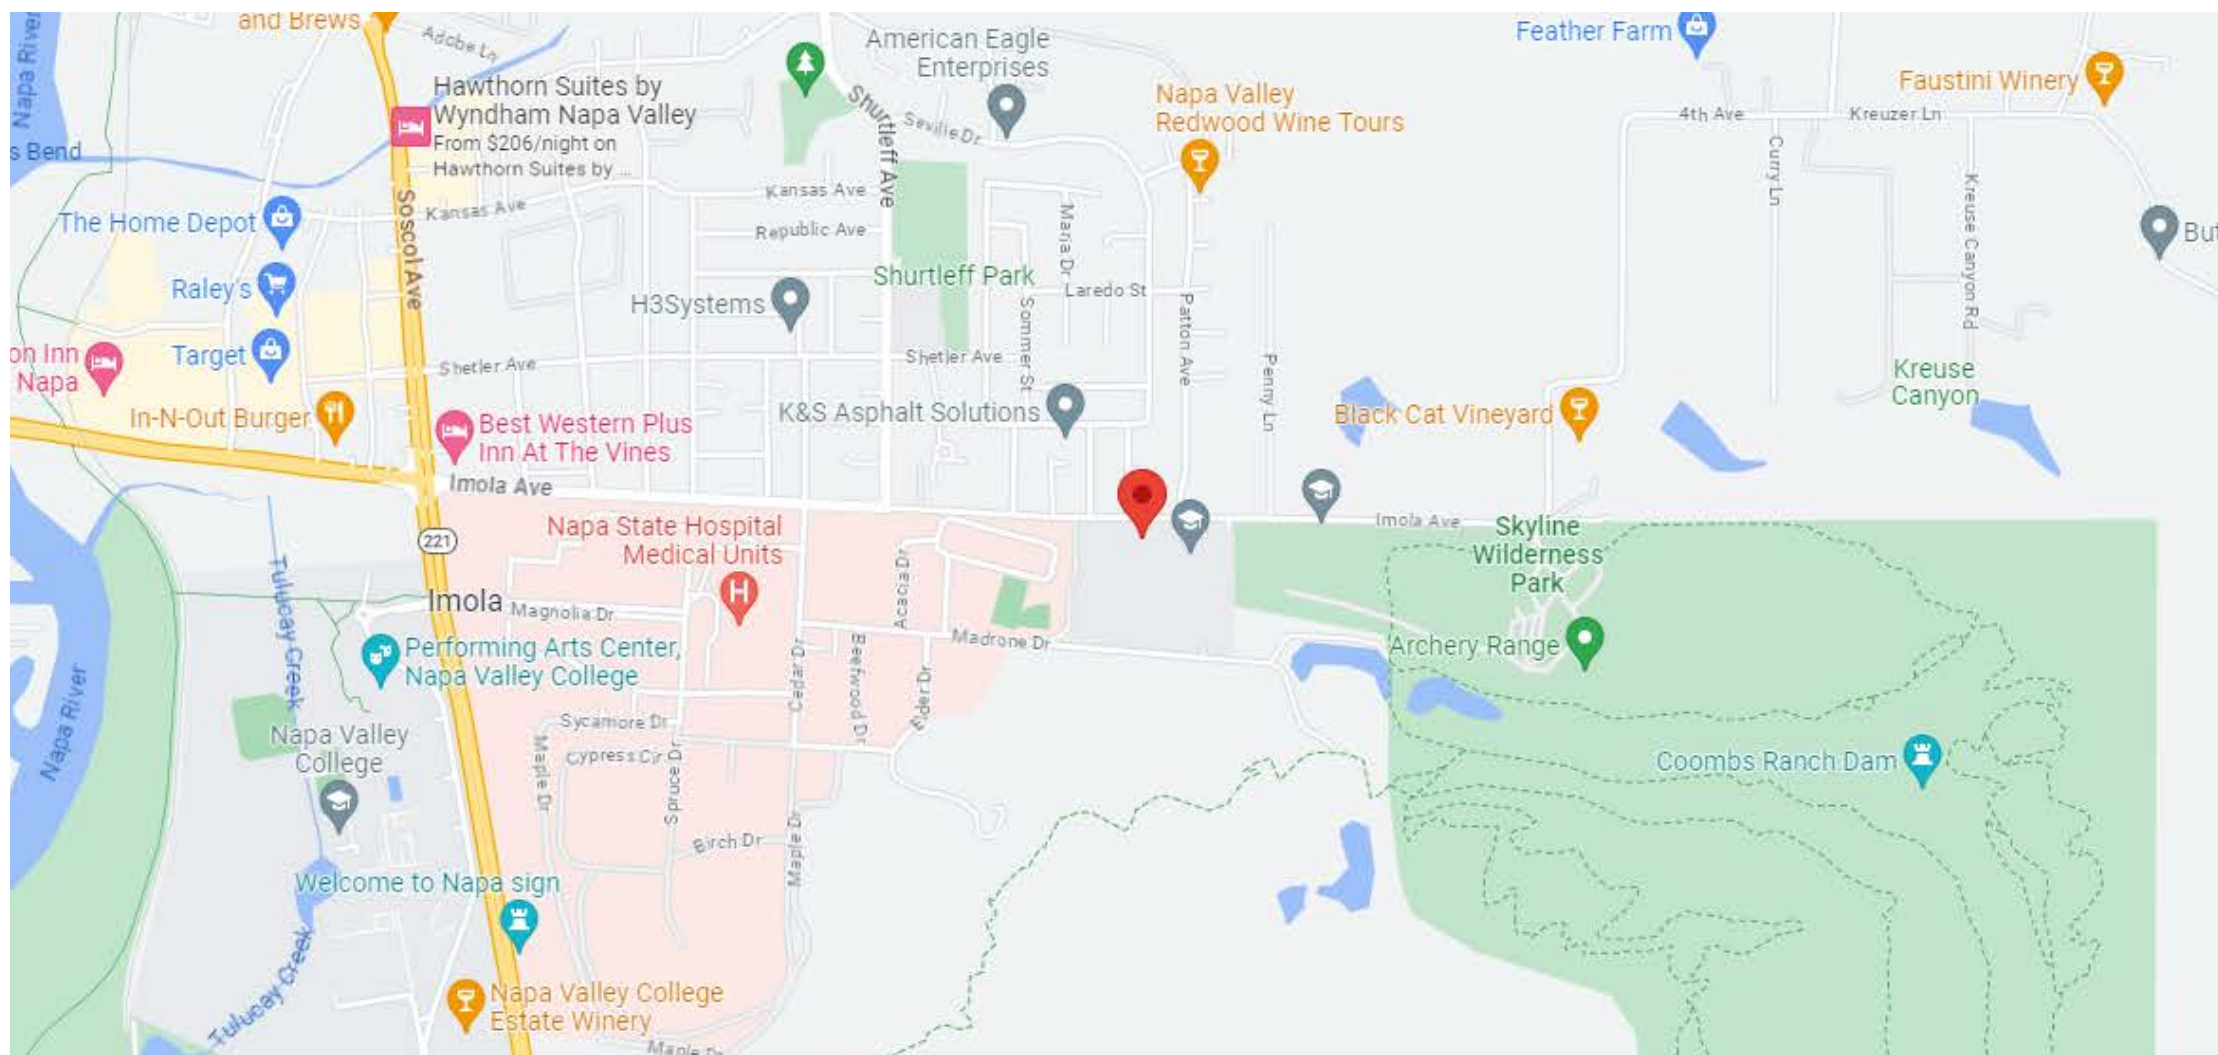

2 LOCUS MAP

0 1250' 2500'

NOT A PART - SEPARATE APPLICATION (A#01-121758)

|                               |                                |
|-------------------------------|--------------------------------|
| BATTERY MODULE ENCLOSURE      | EVO FLEX SERIES 250kW - 500kWh |
| BATTERY SYSTEM CAPACITY (kWh) | 500.00                         |
| BATTERY SYSTEM SIZE (kWac)    | 250.00                         |

#### LIST OF APPLICABLE CODES

2025 California Administrative Code (CAC), Part 1, Title 24 CCR  
2022 California Building Code (CBC), Part 2, Title 24 CCR  
2022 California Electrical Code (CEC), Part 3, Title 24 CCR  
2022 California Mechanical Code (CMC), Part 4, Title 24 CCR  
2022 California Plumbing Code (CPC), Part 5, Title 24 CCR  
2022 California Energy Code, Part 6, Title 24 CCR  
2022 California Fire Code (CFC), Part 9, Title 24 CCR  
2022 California Existing Building Code (CEBC), Part 10, Title 24 CCR  
2022 California Green Building Standards Code (CALGreen), Part 11, Title 24 CCR  
2022 California Referenced Standards Code, Part 12, Title 24 CCR  
Title 19 CCR, Public Safety, State Fire Marshal Regulations  
2020 National Electric Code

#### APPLICABLE STANDARDS

For a list of applicable standards, including California amendments to the NFPA Standards, refer to CBC Chapter 35 and CFC Chapter 80.  
PG&E CONSTRUCTION STANDARDS  
NAPA, CA BUILDING & ELECTRICAL INSPECTORS (AHJs)  
NAPA, CA FIRE DEPARTMENT (AHJs)  
INSTALLING CONTRACTOR AND ALL PERSONNEL ON SITE SHALL FOLLOW APPROPRIATE LOTO PROCEDURES BEFORE SERVICING EQUIPMENT AND SHALL BE EQUIPPED WITH THE APPROPRIATE PPE.

#### SHEET INDEX

| ID    | Name                               | Published                |
|-------|------------------------------------|--------------------------|
| PV001 | BESS SITE PLAN - CC                | <input type="checkbox"/> |
| PV002 | BESS PROP LINES - CC               | <input type="checkbox"/> |
| PV003 | PV SYSTEM NOTES - CC               | <input type="checkbox"/> |
| PV301 | TRENCH & FENCE GROUND DETAILS - CC | <input type="checkbox"/> |
| PV302 | CONDUIT ENTRANCE DETAILS - CC      | <input type="checkbox"/> |
| PV501 | BESS PADS ELEVATION - CC           | <input type="checkbox"/> |
| PV502 | BESS PADS LAYOUT I - CC            | <input type="checkbox"/> |
| PV503 | BESS PADS LAYOUT II - CC           | <input type="checkbox"/> |
| PV504 | EQUIPMENT ELEVATION - CC           | <input type="checkbox"/> |
| PV601 | AC WIRE & COND SCHED - CC          | <input type="checkbox"/> |
| PV602 | SINGLE LINE - CC - OPT 1           | <input type="checkbox"/> |
| PV603 | SINGLE LINE - CC - OPT 2           | <input type="checkbox"/> |
| PV604 | THREE LINE - CC - OPT 1            | <input type="checkbox"/> |
| PV701 | LABELS - ADMIN                     | <input type="checkbox"/> |
| PV801 | DATASHEETS - ADMIN                 | <input type="checkbox"/> |



ARCHITECT PRK Architects, Inc.  
FOLSOM  
1110 Iron Point Road, Suite 200  
Folsom, CA 95630-8515  
916-355-9922

CAMILLE CREEK COMMUNITY SCHOOL - BATTERIES ENCLOSURE

NAPA COUNTY OFFICE OF EDUCATION  
CAMILLE CREEK COMMUNITY SCHOOL


2097 IMOLA AVE, NAPA, CA 94558  
PTN: 1-0280-21, DSA# 01-12276

DESIGN DEVELOPMENT



HARVARD, MA 01451-0242 Tel: 978-456-6855  
www.solar-design.com Fax: 978-772-8716

KEY PLAN

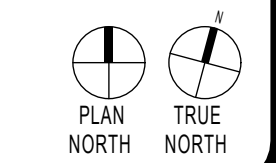

| CLIENT                   |                            |            |
|--------------------------|----------------------------|------------|
| NCOE                     |                            |            |
| PROJECT NUMBER           |                            |            |
| 250118                   |                            |            |
| DATE                     |                            |            |
| Thursday, April 30, 2026 |                            |            |
| DRAWN BY                 |                            |            |
| MJ                       |                            |            |
| CHECKED BY               |                            |            |
| CW/HS, TP                |                            |            |
| REVISIONS                |                            |            |
| #                        | DESCRIPTION                | DATE       |
| 1                        | DESIGN DEVELOPMENT SET     | 04/23/2026 |
| 2                        | CONSTRUCTION DOCUMENTS SET | 07/03/2026 |
| 1                        | BESS UPDATE                | 07/03/2026 |
| 2                        | BESS UPDATE                | 03/19/2026 |
| 1                        | PRK EDITS                  | 04/30/2026 |
| 3                        | ADDENDUM 1                 | 08/24/2026 |

DESIGN DEVELOPMENT  
BESS SITE PLAN - CC

PV001